



**ELECTRICAL PLAN**

DRAWN BY  
**B. McNabb**  
 DATE  
**10-17-2004**  
 SCALE  
**AS NOTED**  
 PROJECT  
**BARBARO**  
 SHEET

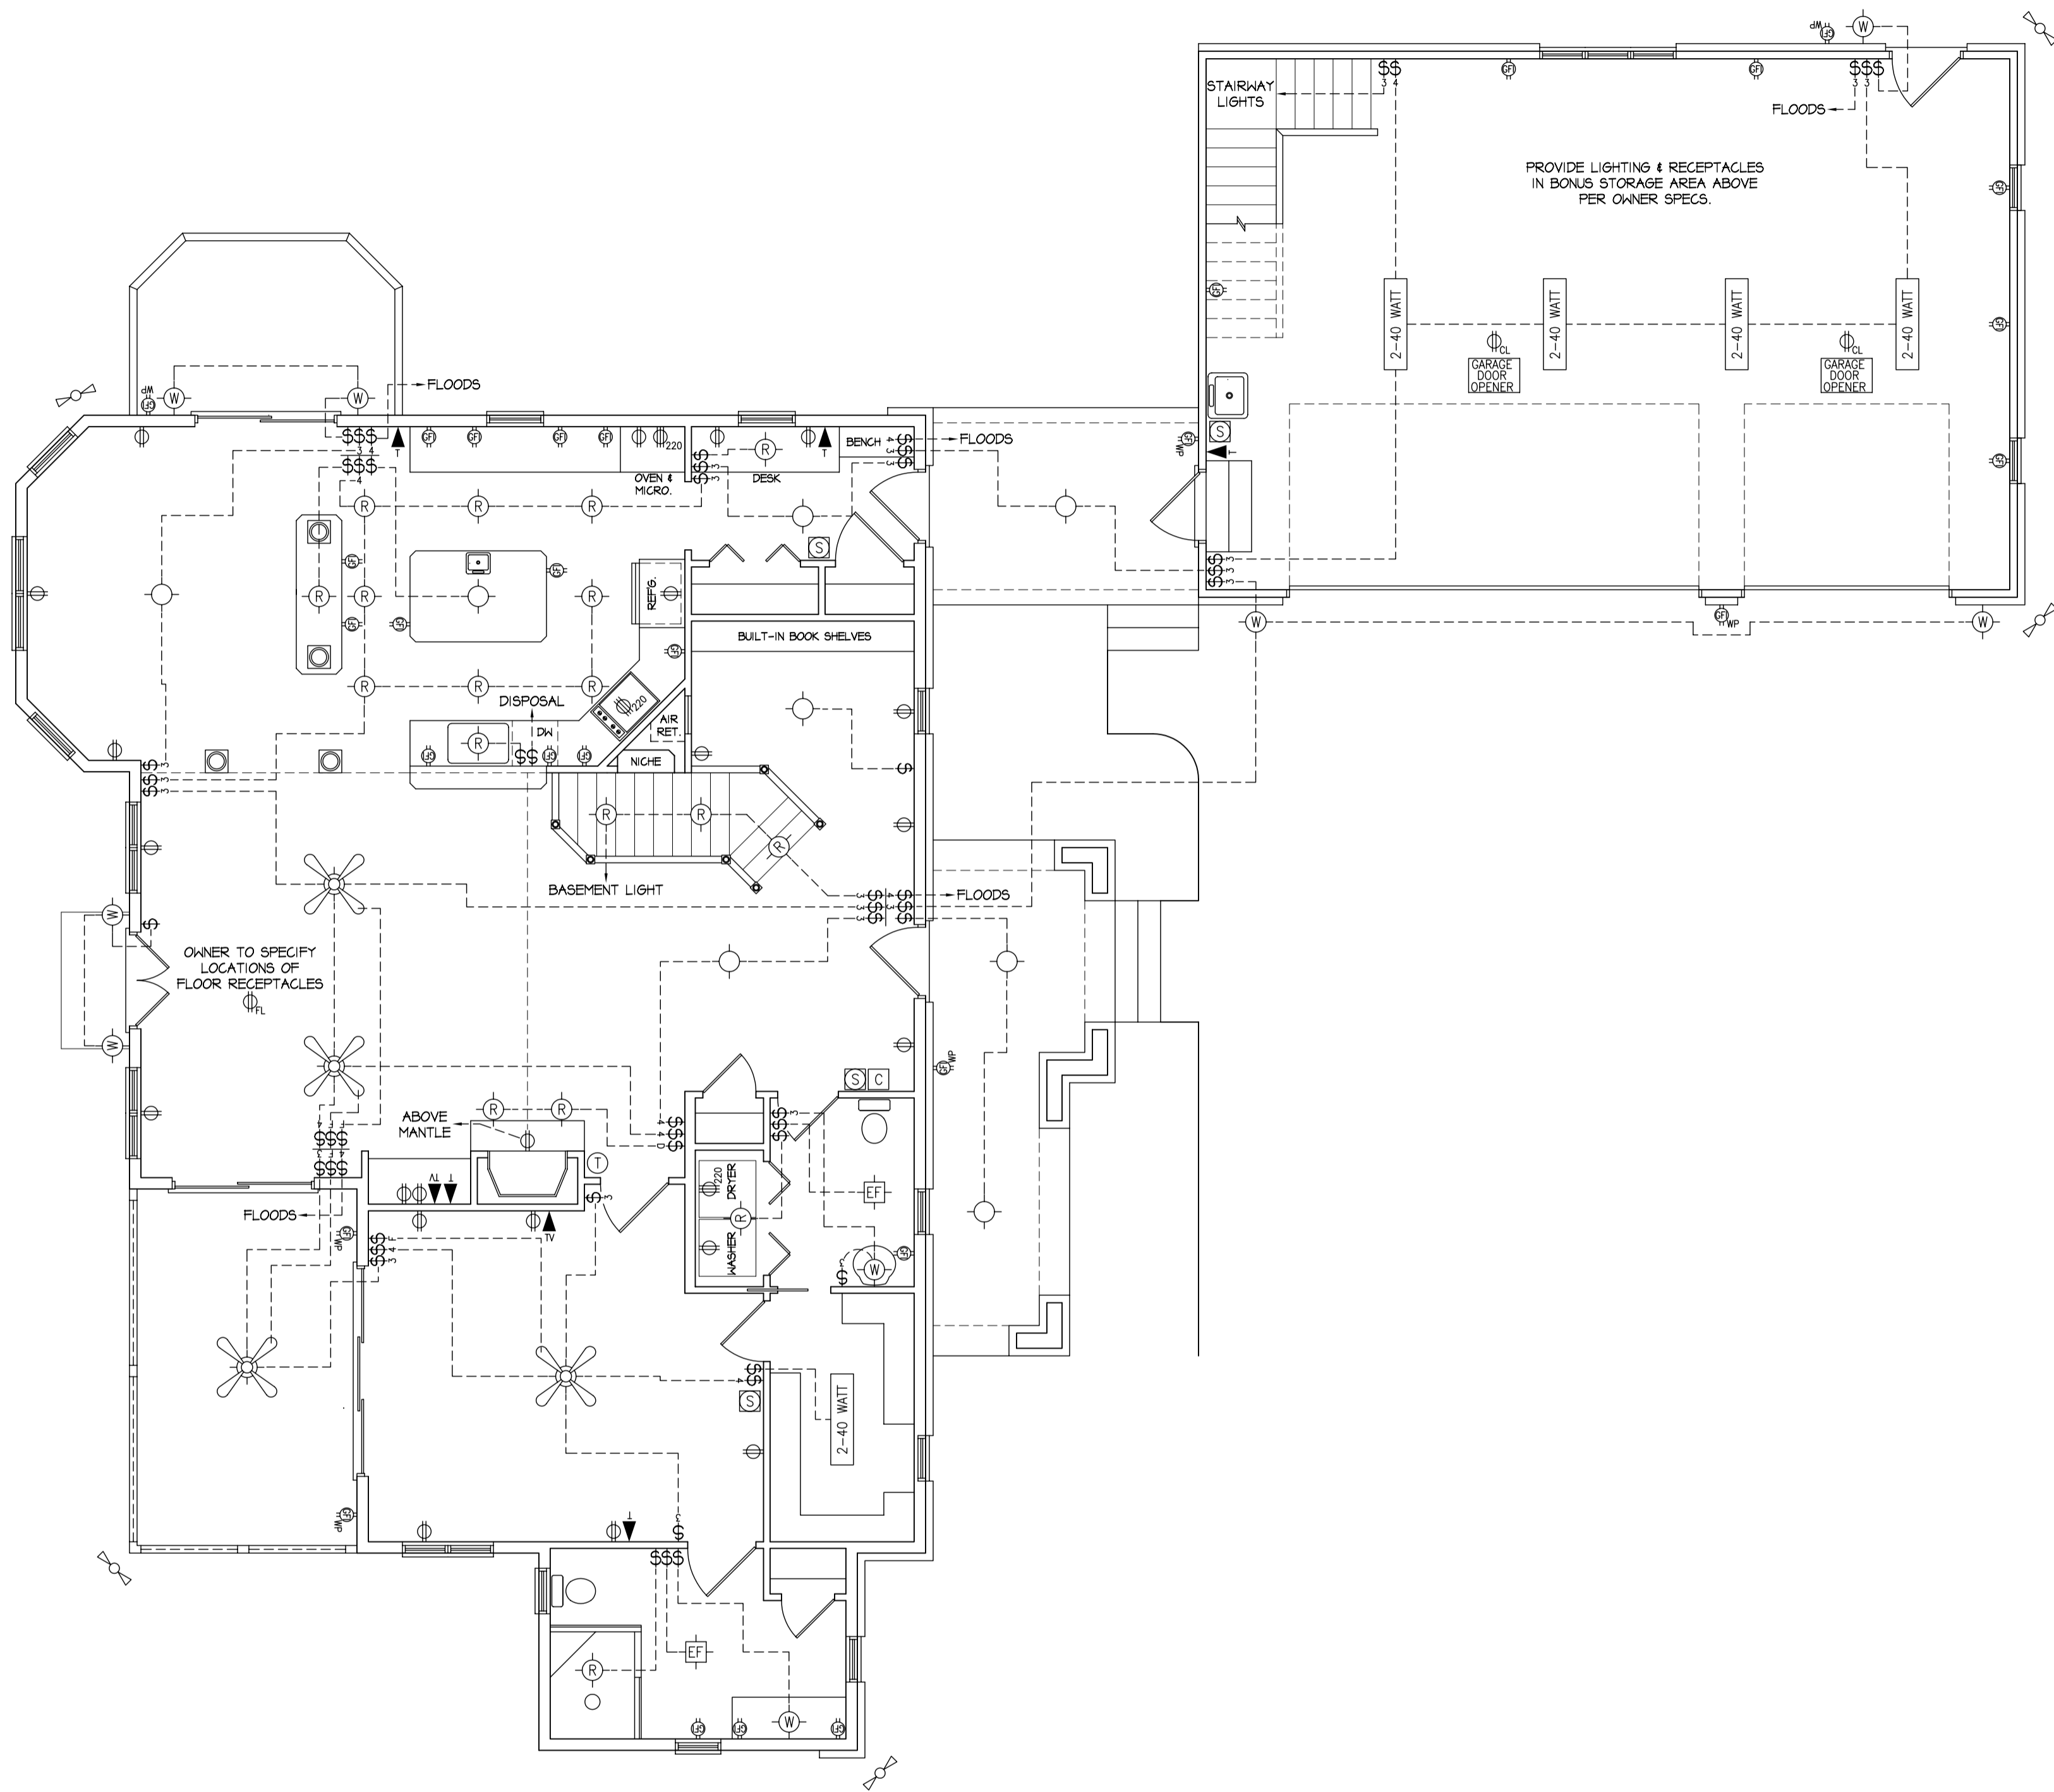

**MAIN FLOOR ELECTRICAL**  
 SCALE: 3/16" = 1'-0"

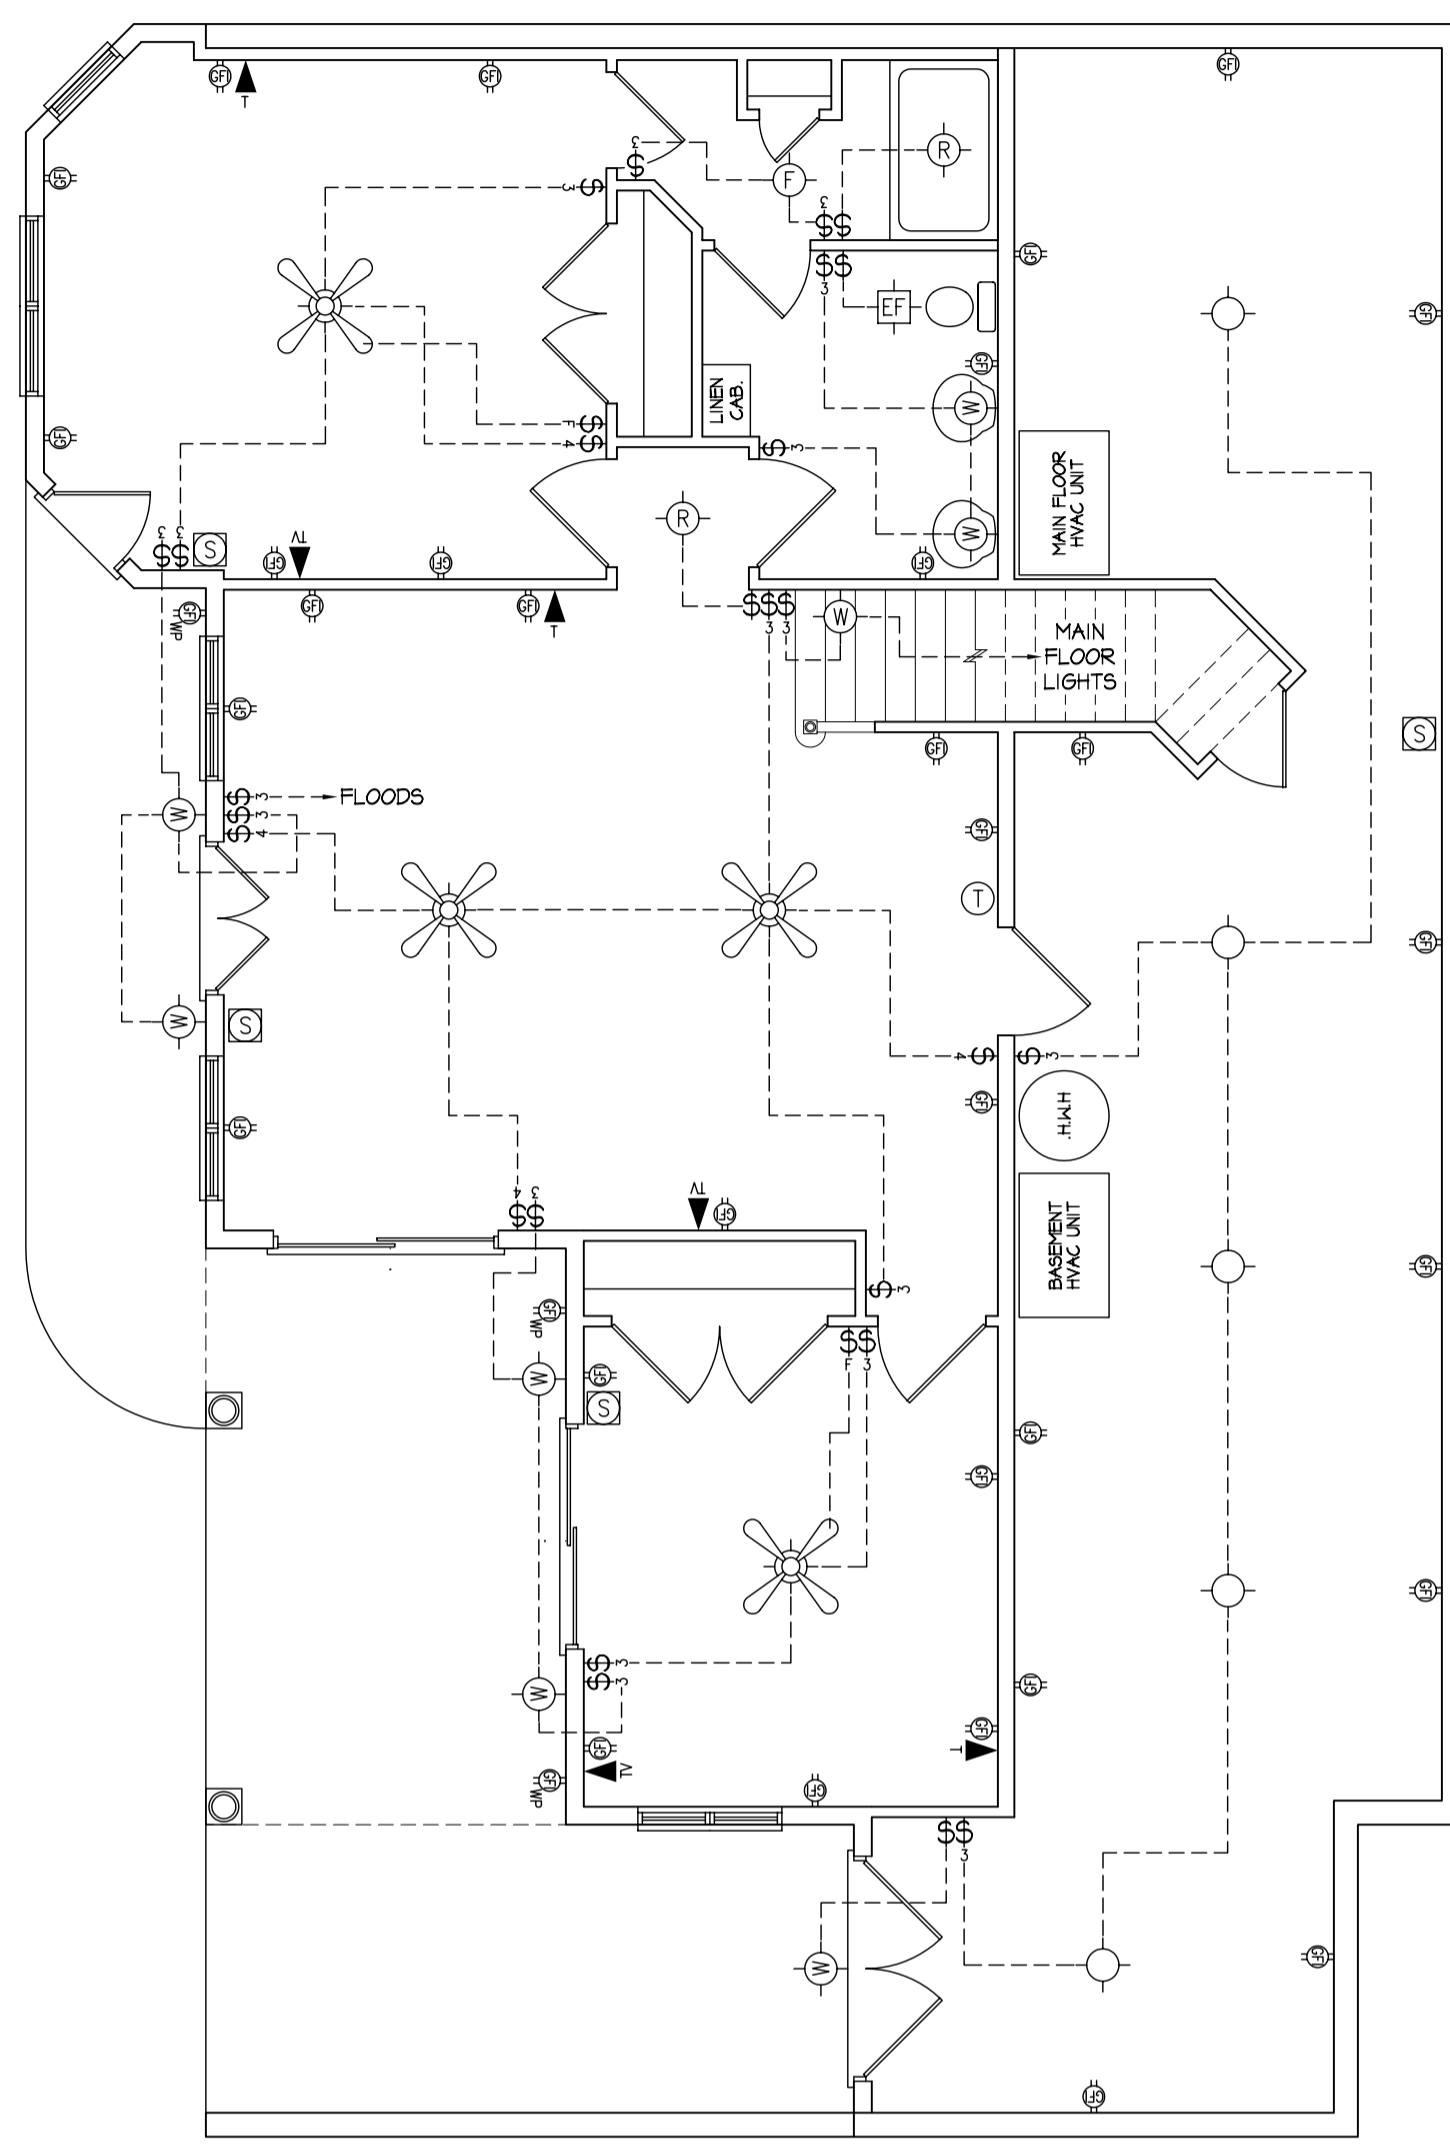

**BASEMENT ELECTRICAL**  
 SCALE: 3/16" = 1'-0"

**ELECTRICAL SYMBOLS:**

- |   |                              |
|---|------------------------------|
| ⊕ RECEPTACLE  | DB DOOR BELL                 |
| ⊕ <sub>R</sub> FLOOR RECEPTACLE                     | Ⓢ THERMOSTAT                 |
| ⊕ <sub>C</sub> CEILING RECEPTACLE                   | Ⓢ CHIMES                     |
| ⊕ <sub>GFCI</sub> GROUND FAULT PROTECTED RECEPTACLE | Ⓢ MULTI-STATION SMOKE ALARM  |
| ⊕ <sub>220</sub> 220v APPLIANCE RECEPTACLE          | Ⓢ LIGHT FIXTURE              |
| ⊕ <sub>WP</sub> RECEPTACLE W/ WEATHERPROOF COVER    | Ⓢ WALL MOUNT LIGHT FIXTURE   |
| Ⓢ SINGLE POLE SWITCH                                | Ⓢ RECESSED LIGHT FIXTURE     |
| Ⓢ <sub>3</sub> THREE-WAY SWITCH                     | Ⓢ EXHAUST FAN                |
| Ⓢ <sub>4</sub> FOUR-WAY SWITCH                      | Ⓢ EXHAUST FAN & LIGHT        |
| Ⓢ <sub>D</sub> DIMMER SWITCH                        | Ⓢ EXHAUST FAN, LIGHT, HEATER |
| Ⓢ <sub>T</sub> TIMER                                | Ⓢ FLOOD LIGHT                |
| Ⓢ <sub>F</sub> FAN CONTROLLER                       |                              |
| ▲ TELEPHONE OUTLET                                  |                              |
| ▲ CATV OUTLET                                       |                              |

**BRUNO BARBARO**  
**LOT 5-BLOCK 12**  
**KAHITE**

TOTAL FINISHED AREA: 2750 SQ. FT.	
MAIN FLOOR:	1780 SQ. FT.
GARAGE:	860 SQ. FT.
BASEMENT FINISHED:	970 SQ. FT.
BASEMENT UNFINISHED:	810 SQ. FT.
COVERED ENTRY:	160 SQ. FT.
COVERED BREEZEWAY:	96 SQ. FT.
GRILLING DECK:	90 SQ. FT.
SCREEN PORCH:	160 SQ. FT.

COPYRIGHT © 2004. ALL RIGHTS RESERVED.  
 THIS PLAN IS NOT TO BE REPRODUCED IN ANY FORM.

REVISED FINAL #1